


INSTALL LIGHTS AND EMERGENCY LIGHTS TO STAIR (4.00)

● INSTALL FIRE ALARM SYSTEM THROUGHOUT. (10.00)

SEE PLAN
 SEE PLAN
 SEE PLAN
 SEE PLAN

THE COURT BUILDING
 BASEMENT PLAN

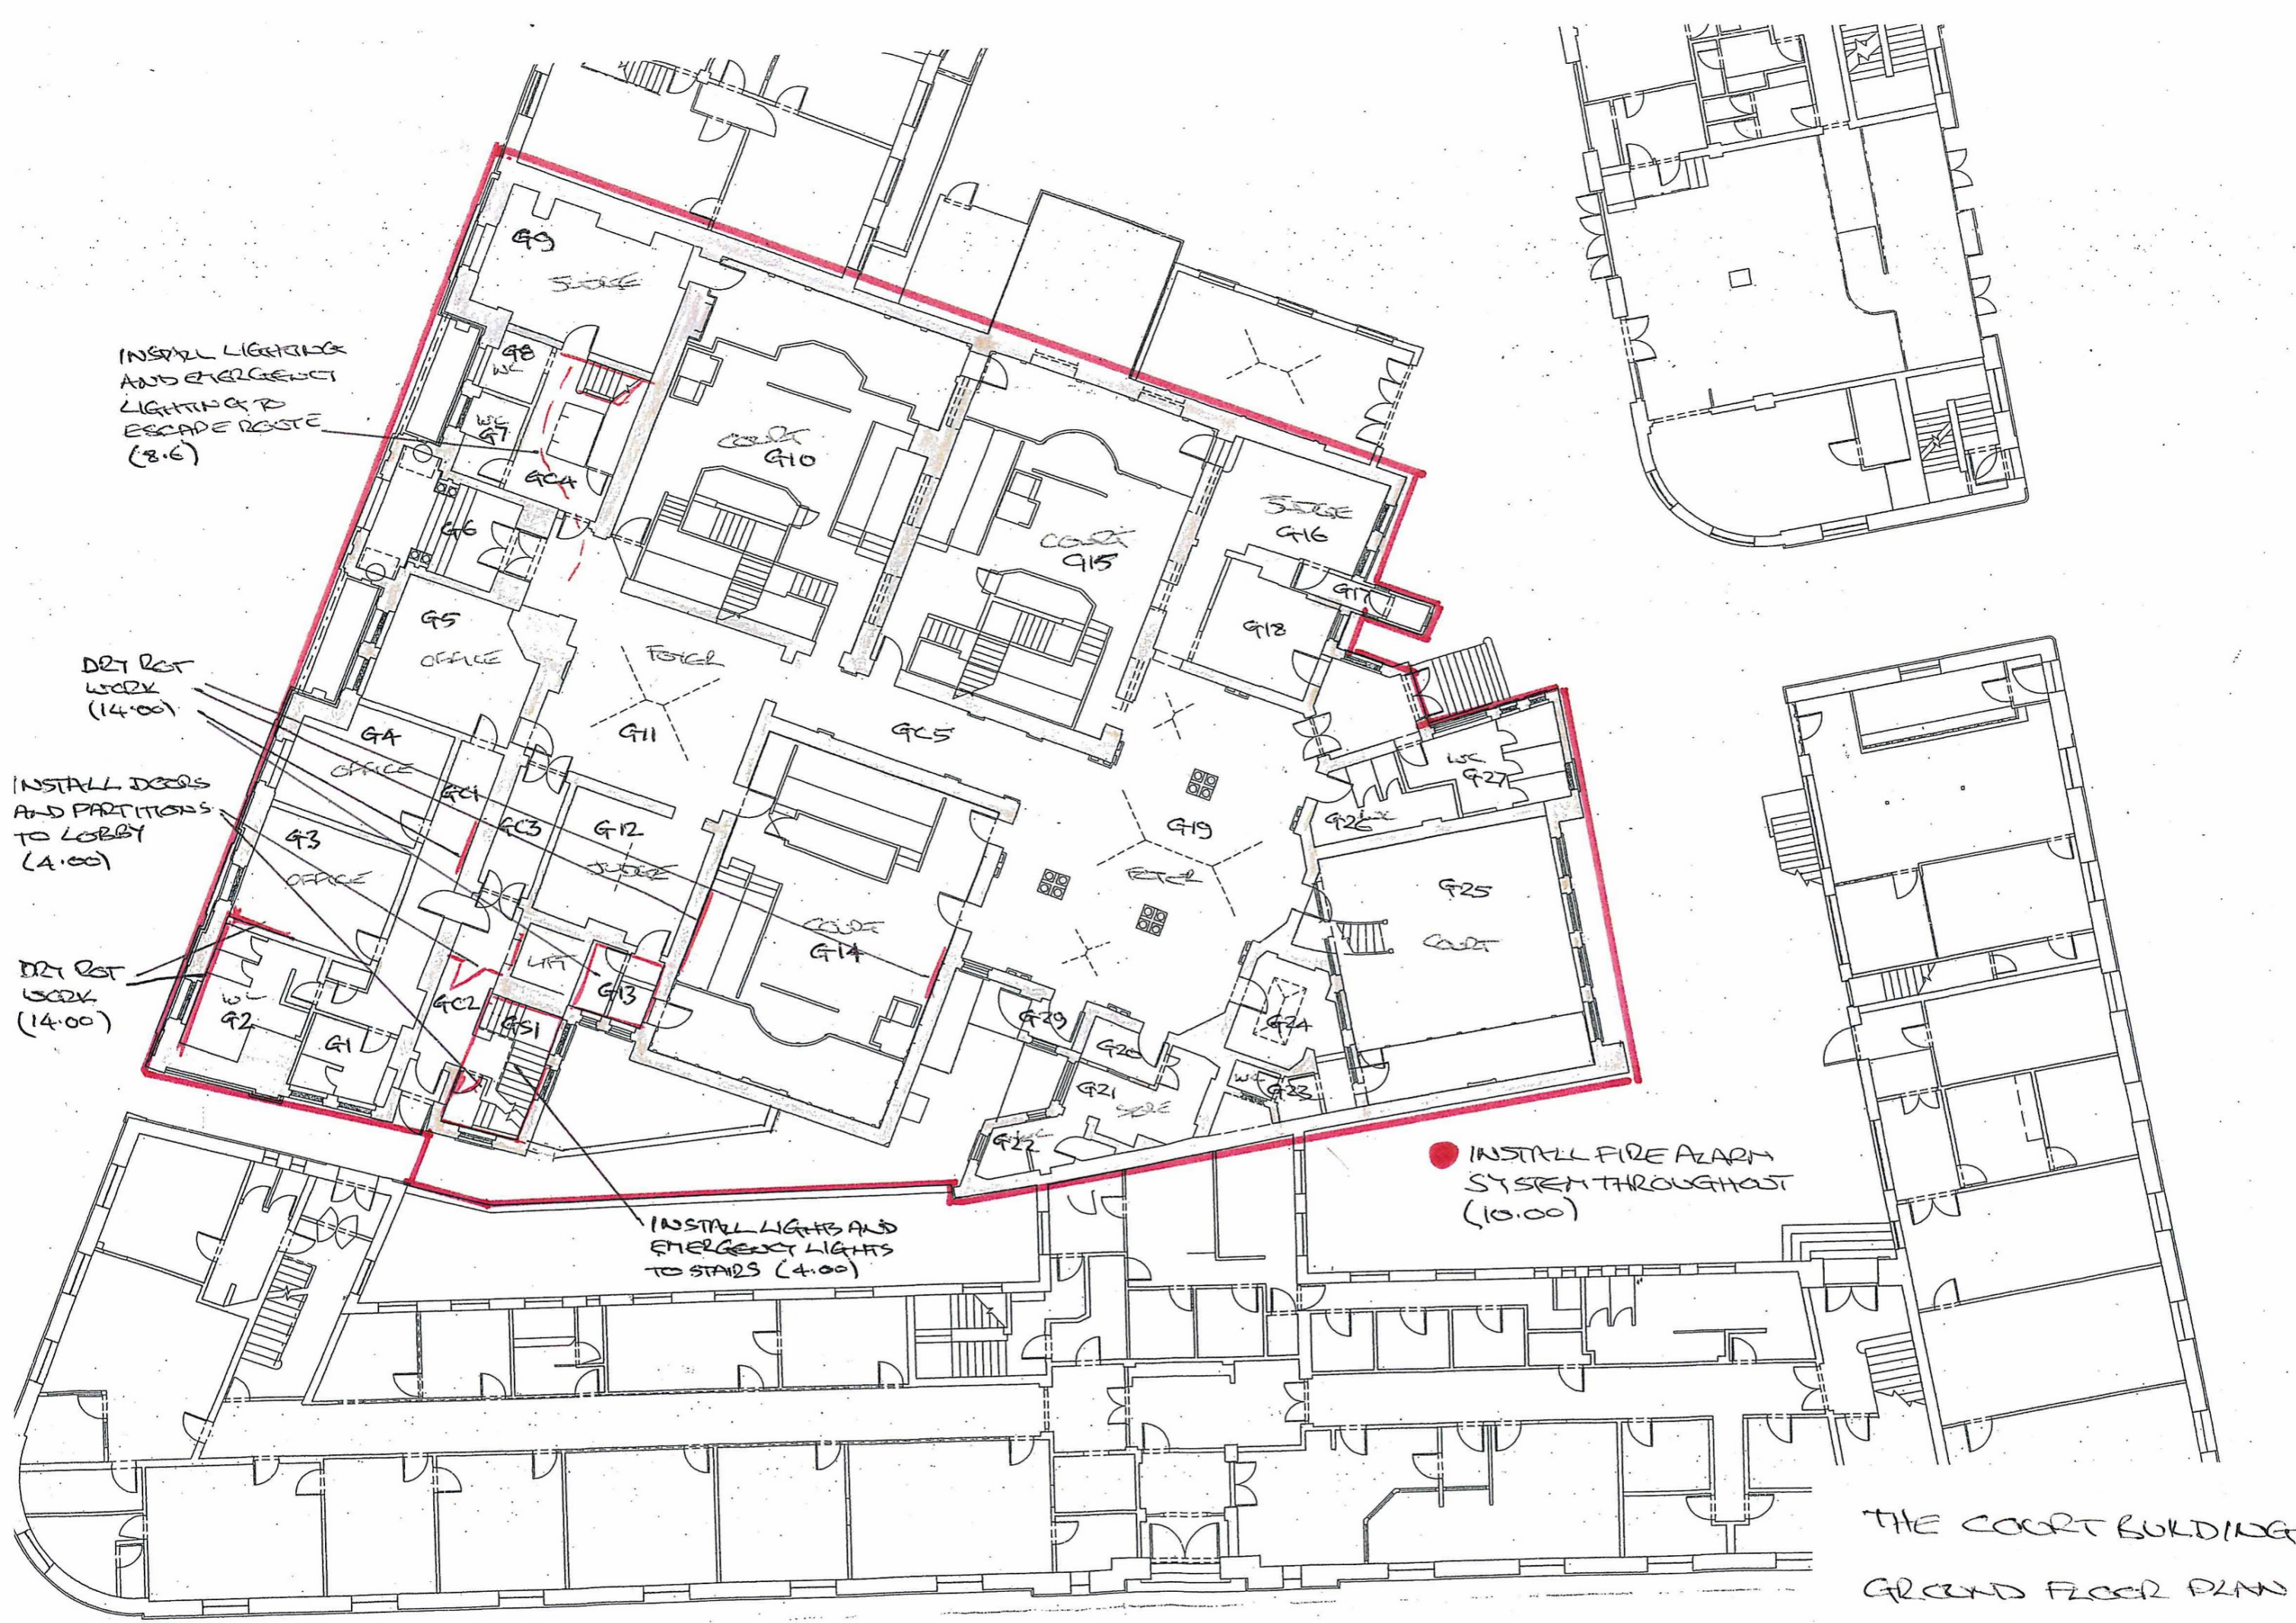

INSTALL LIGHTING AND EMERGENCY LIGHTING & ESCAPE ROUTE (8.6)

D21 RST WORK (14.00)




INSTALL DOORS AND PARTITIONS TO LOBBY (4.00)

D21 RST WORK (14.00)

INSTALL LIGHTS AND EMERGENCY LIGHTS TO STAIRS (4.00)

● INSTALL FIRE ALARM SYSTEM THROUGHOUT (10.00)

THE COURT BUILDING
 GROUND FLOOR PLAN
 Scale 1:200 @ A3

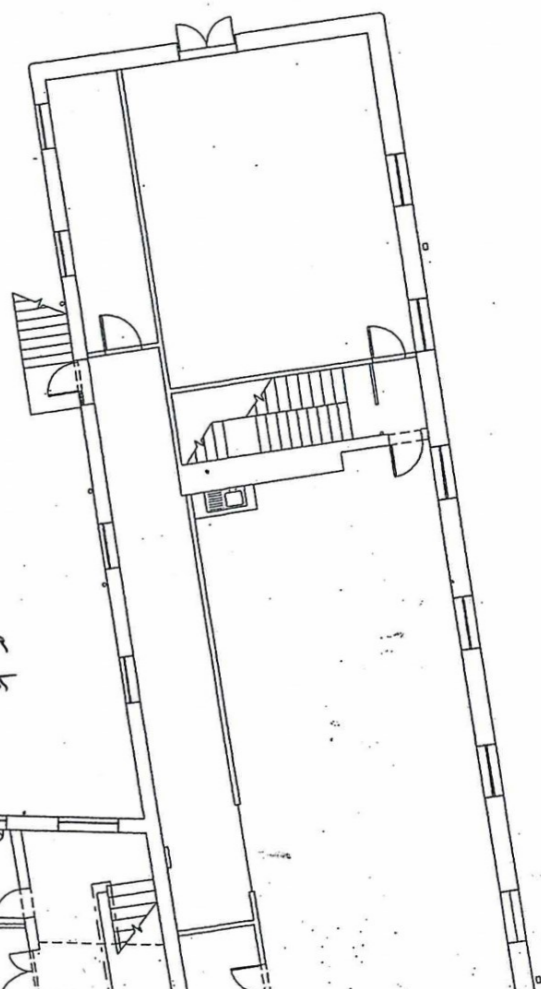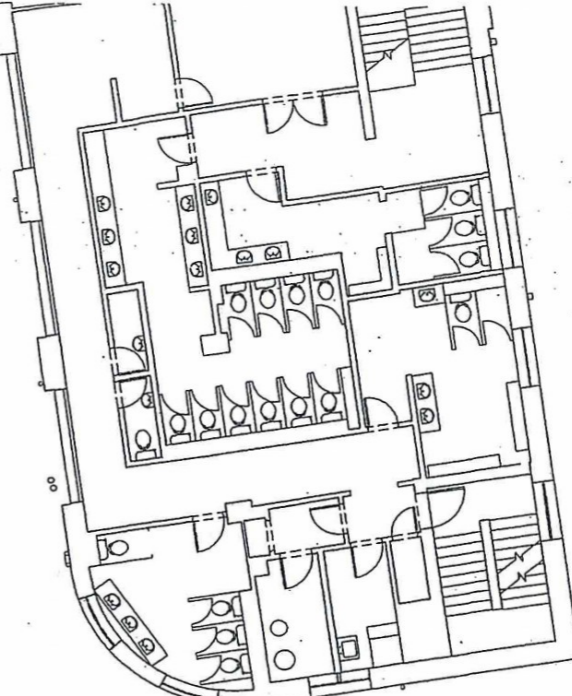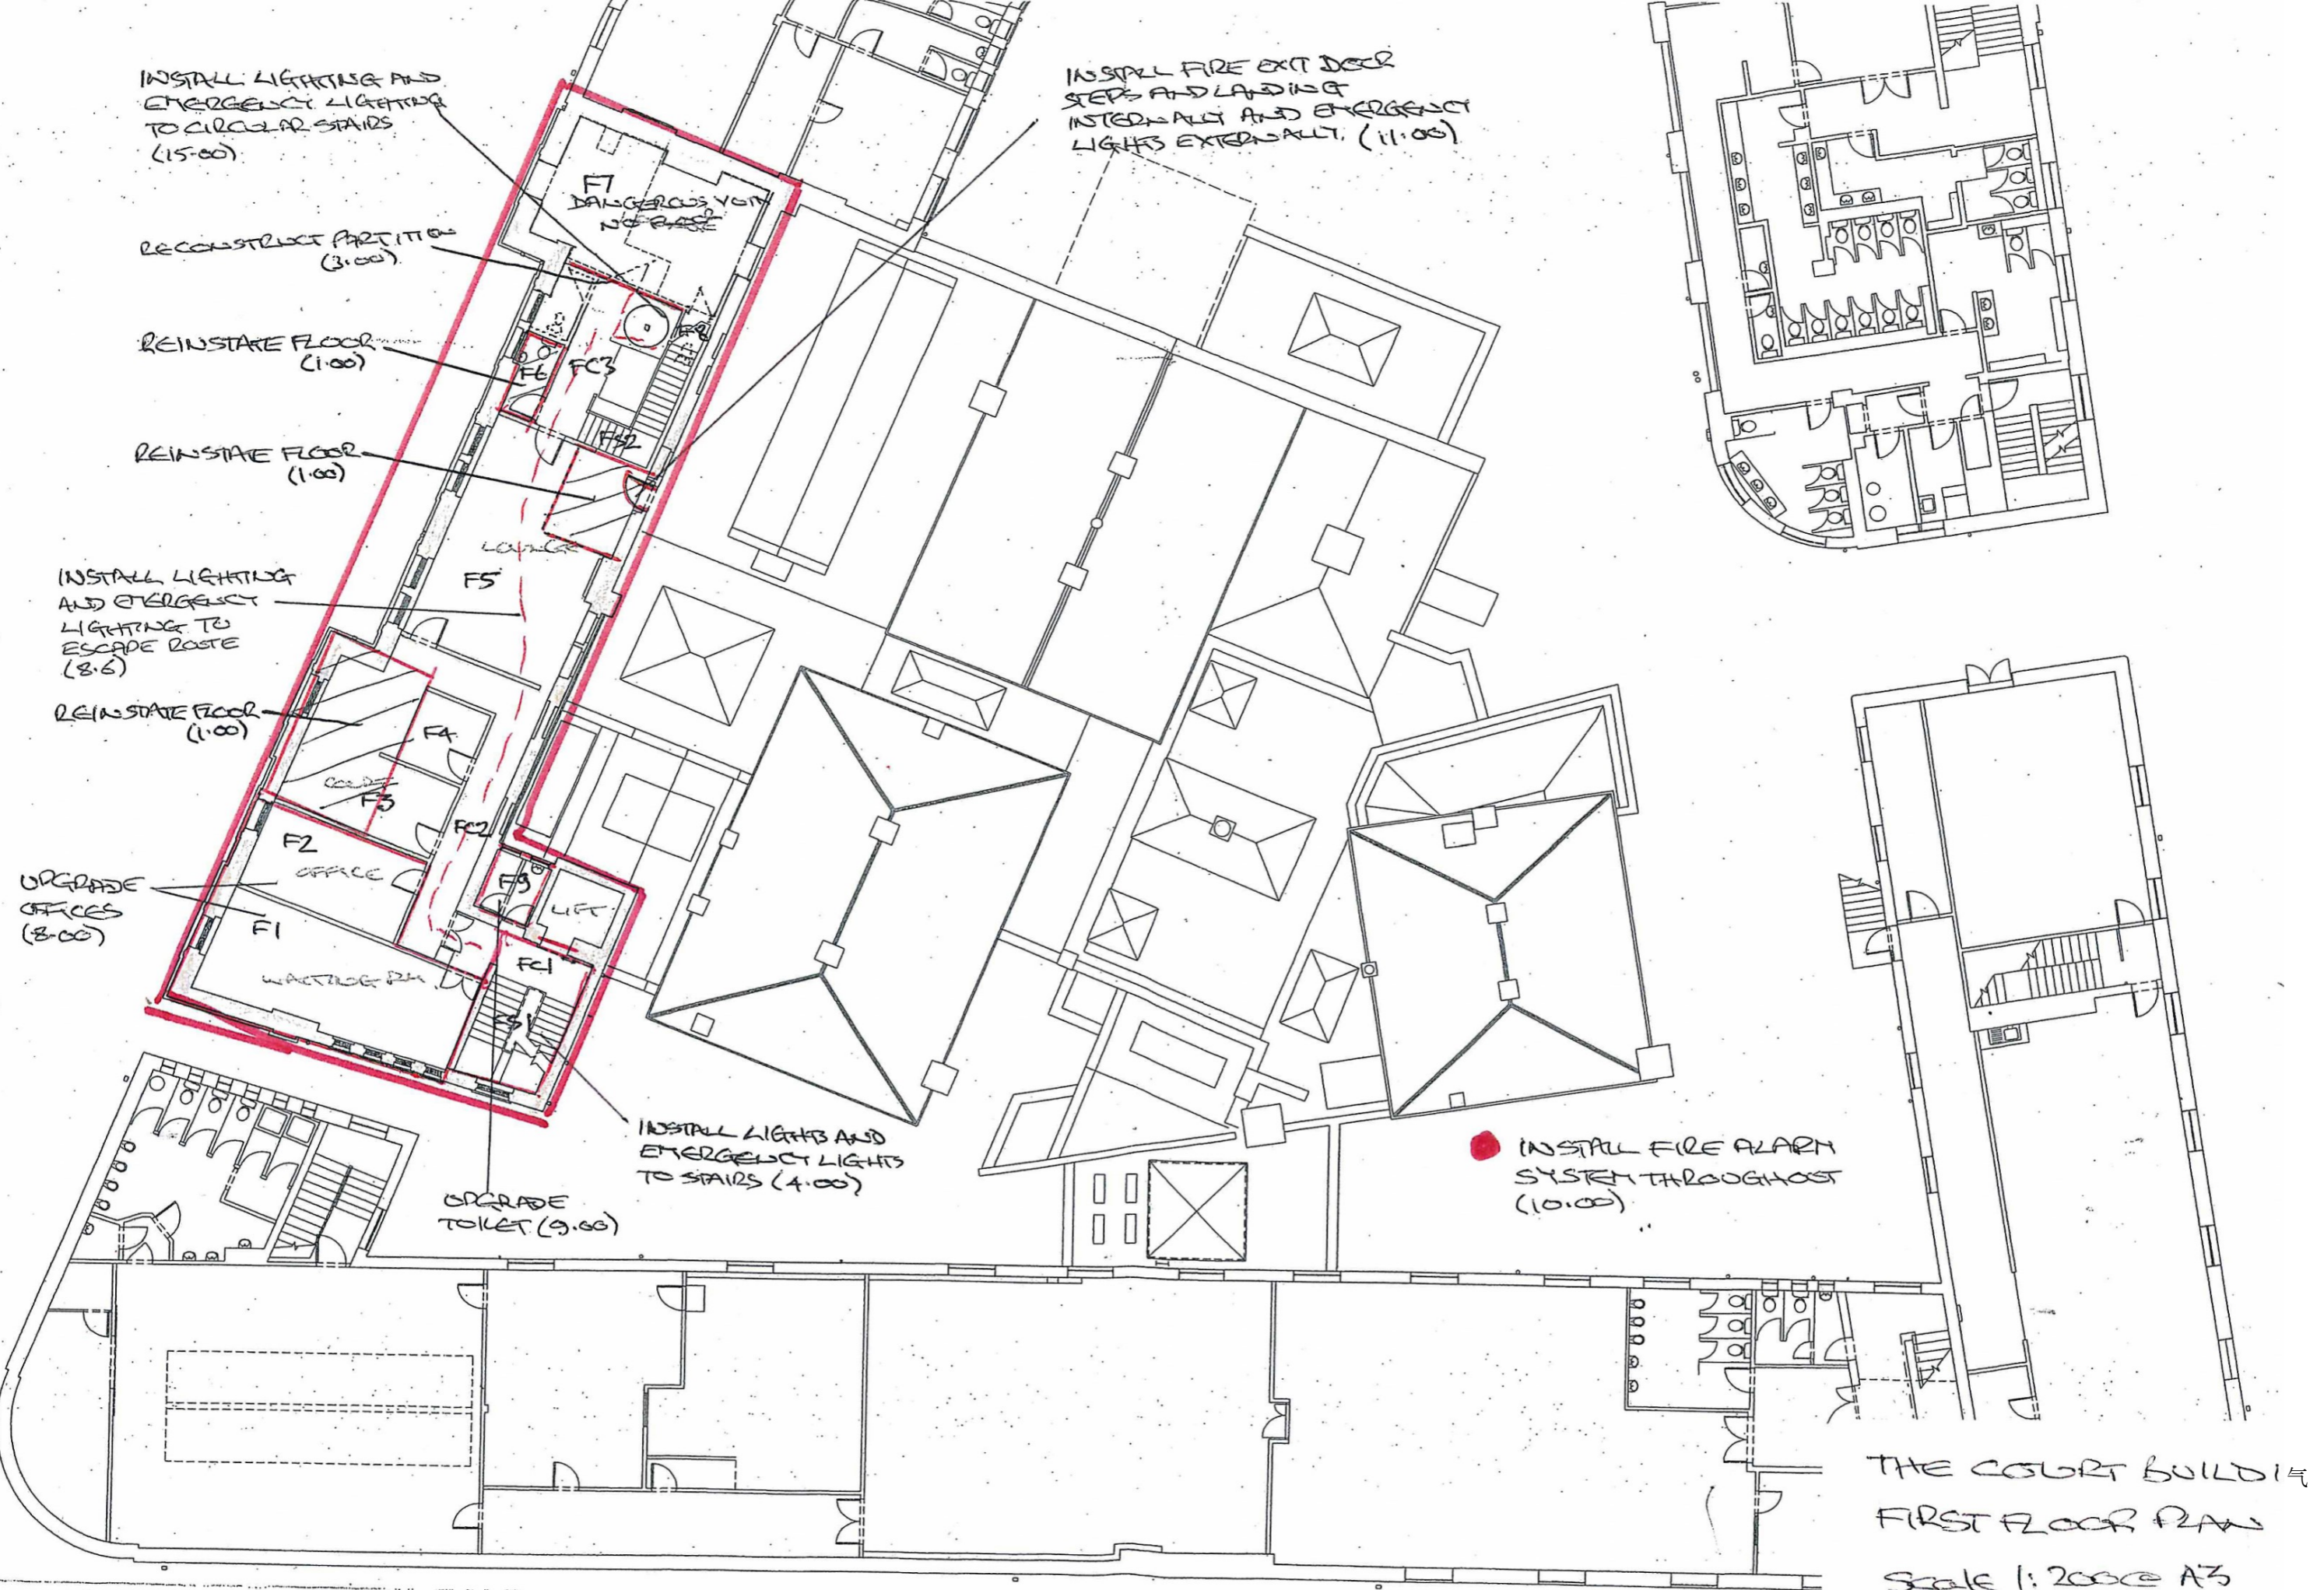

THE COURT BUILDING
 FIRST FLOOR PLAN
 SCALE 1:2000 @ A3

乙い[口 ~


2、ド

へしな、し、(せし)

GSC-R マト - ユむ
自◇5 「OC
この

広一氏[(i-c。 2

つ(ゝ:文をべろ

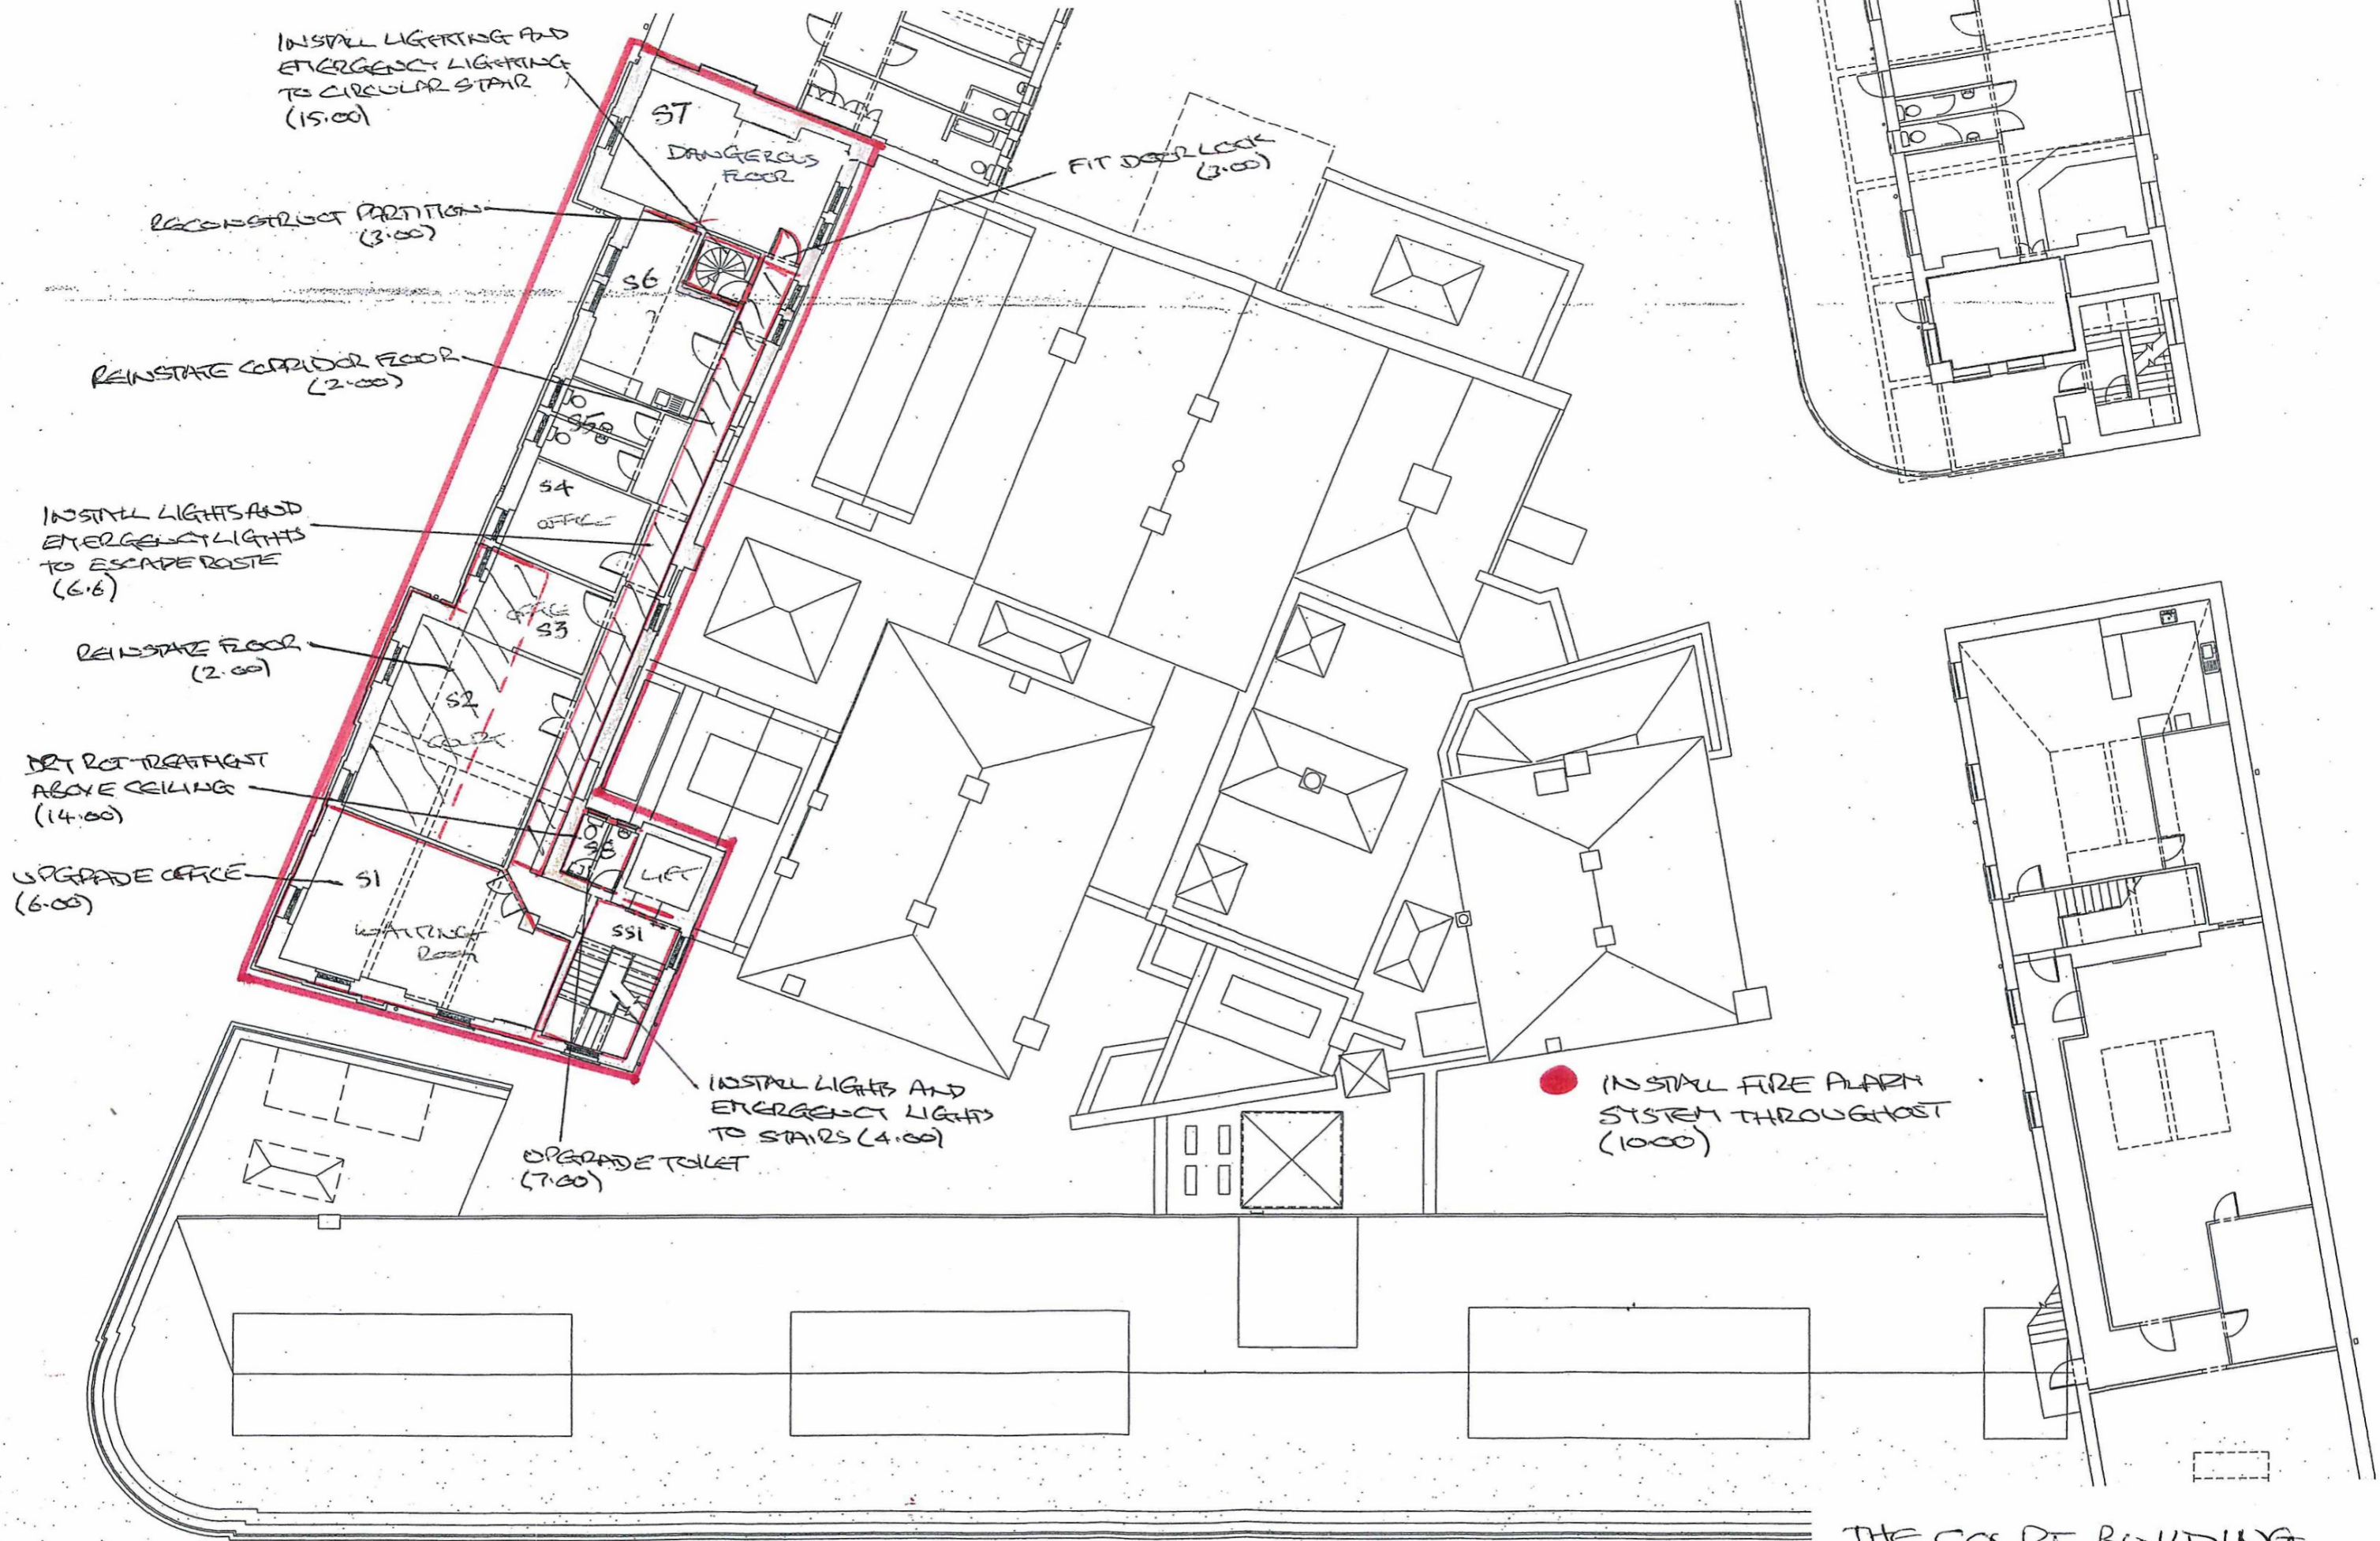

INSTALL LIGHTING AND EMERGENCY LIGHTING TO CIRCULAR STAIR (15.00)

RECONSTRUCT PARTITION (3.00)

REINSTATE CORRIDOR FLOOR (2.00)

INSTALL LIGHTS AND EMERGENCY LIGHTS TO ESCAPE ROUTE (6.6)

REINSTATE FLOOR (2.00)

FIT RETREATMENT ABOVE CEILING (14.00)

UPGRADE OFFICE (6.00)


INSTALL LIGHTS AND EMERGENCY LIGHTS TO STAIRS (4.00)

UPGRADE TOILET (7.00)

FIT DOOR LOCK (3.00)

INSTALL FIRE ALARM SYSTEM THROUGHOUT (1000)

THE COURT BUILDING
SECOND FLOOR PLAN
Scale 1:200 @ A3

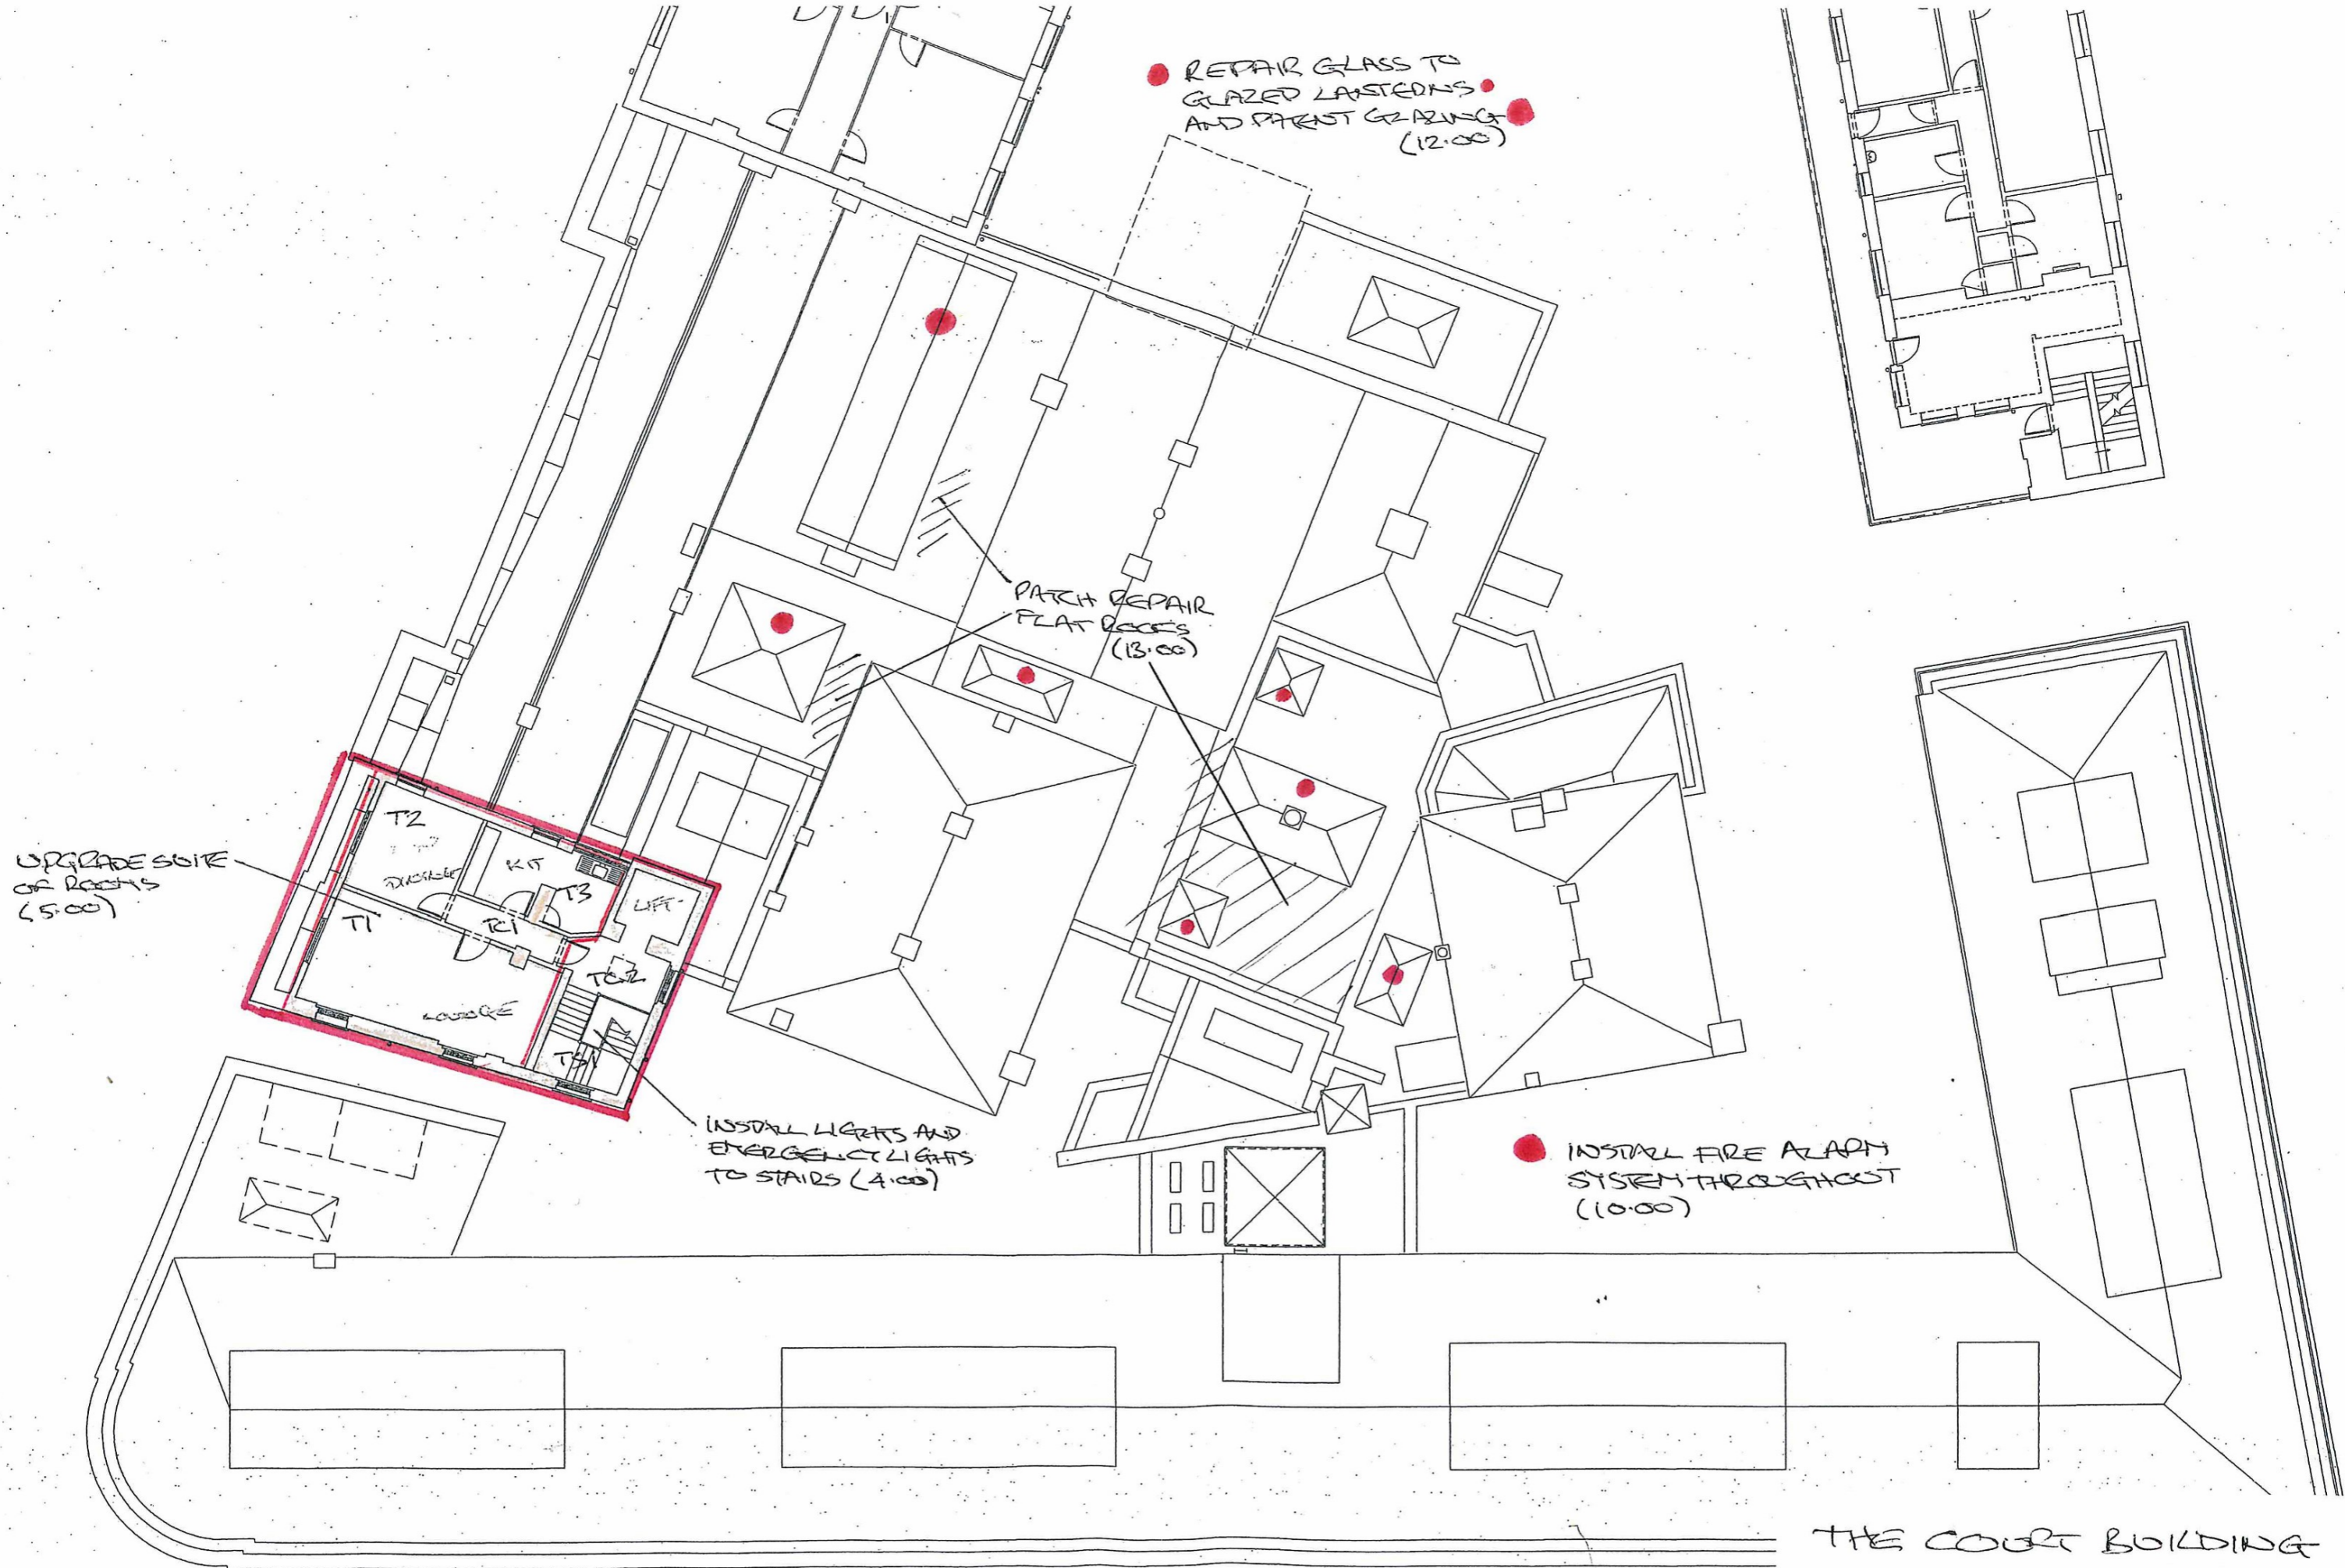

THE COURT BUILDING
 THIRD FLOOR PLAN AND
 LOWER FLOORS ROOF PLAN
 Scale 1:200 @ A3