




PLAN OF PROPOSED LAYOUT

SCALE 1 : 200

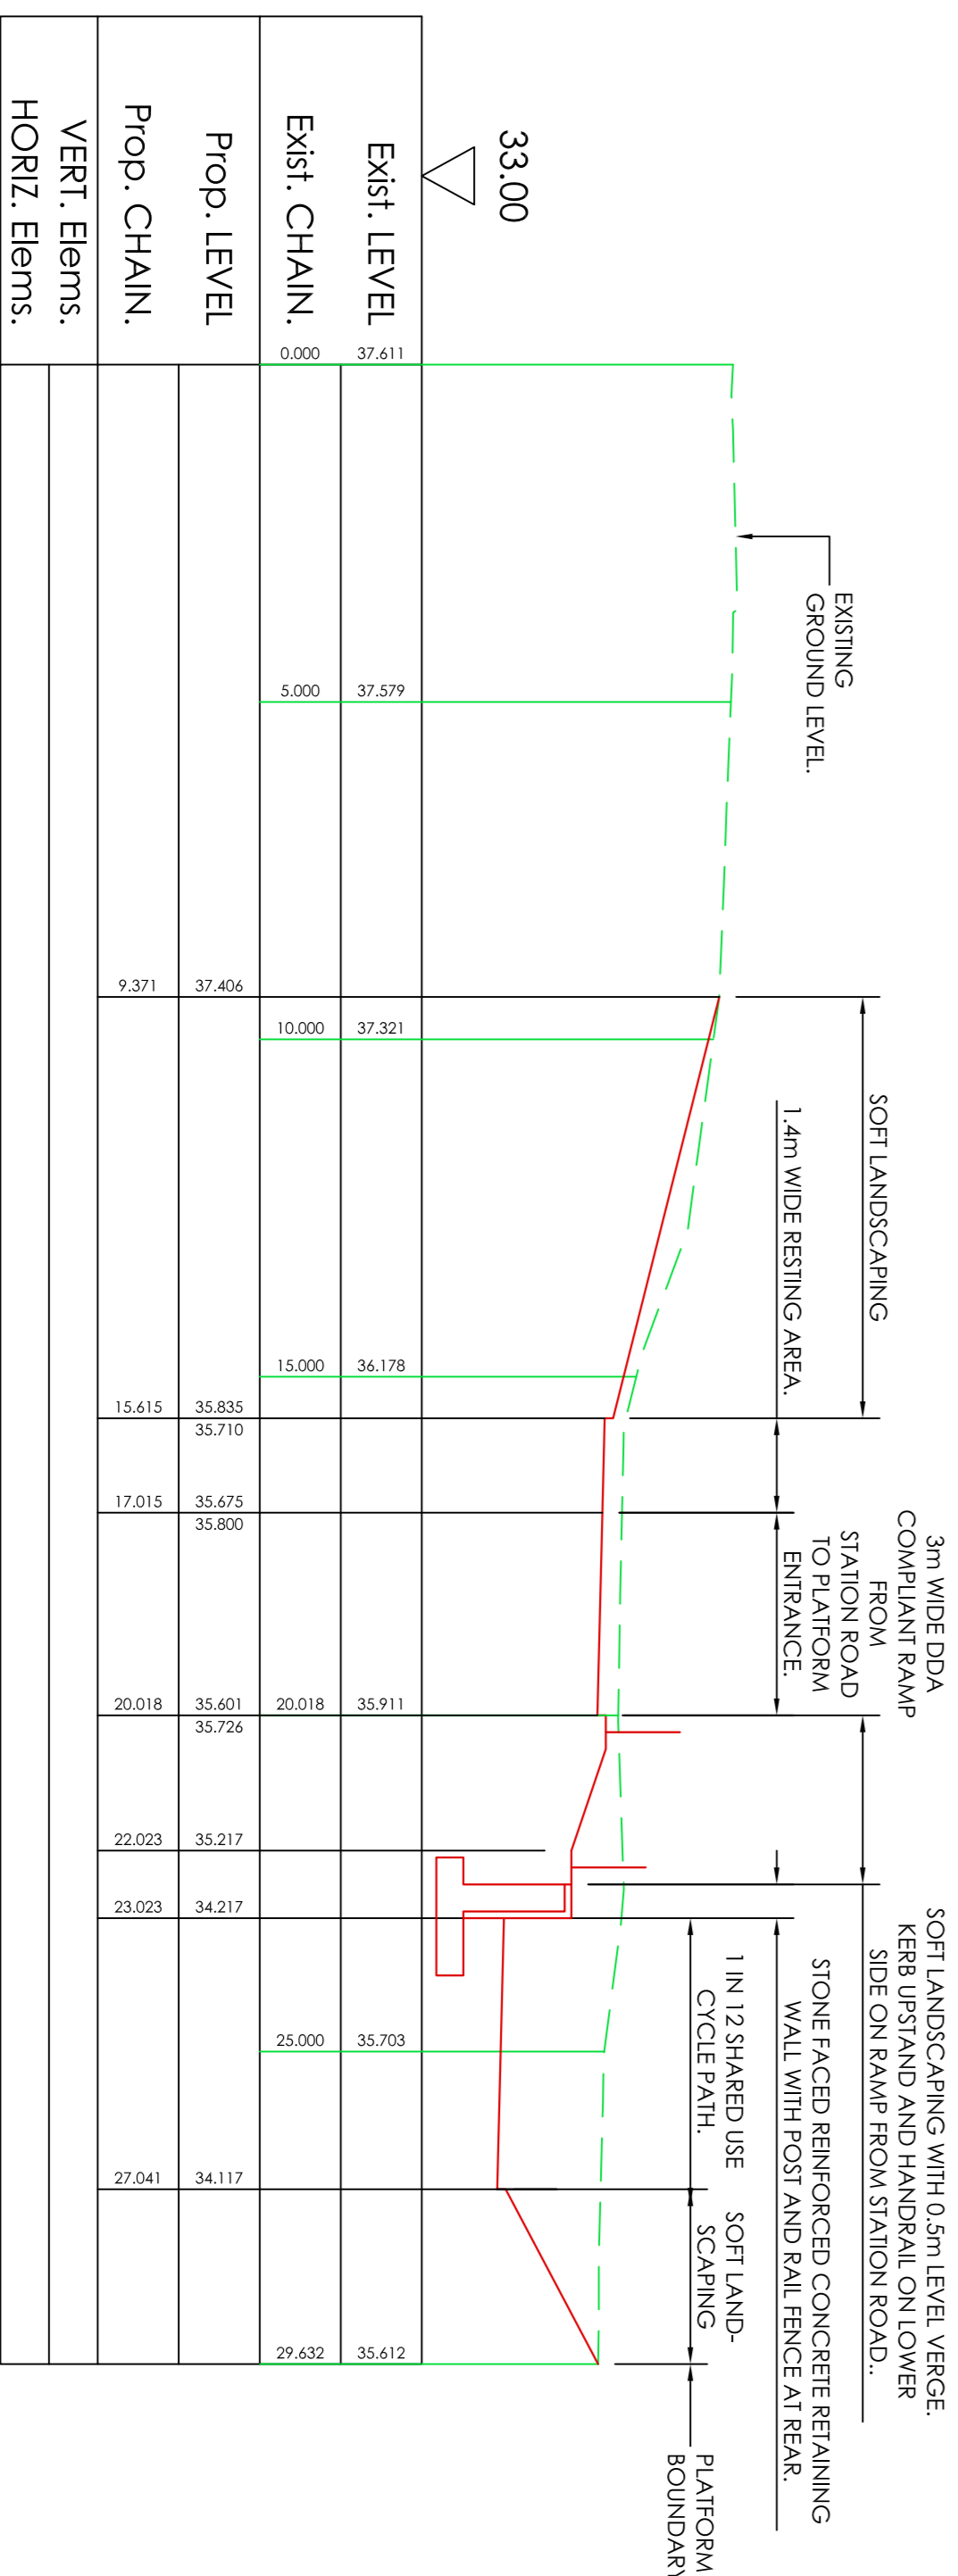

SECTION A-A TYPICAL CROSS SECTION

SCALE 1 : 100

- TREE RECOMMENDED FOR REMOVAL
- PROPOSED BOLLARD
- EXISTING LIGHTING COLUMN
- PROPOSED TREE  
QUERCUS ROBUR, BETULA PENDULA, SORBUS AUCUPARIA, PRUNUS PADUS
- MEADOW GRASS: IE, EMORSGATE E/M4 MIX
- SLDS RAINGARDEN PLANTING SWALE
- NATIVE SPRING BULBS  
NARCISSUS, GALANTHUS, HYACINTHOIDES, CROCUS
- NATIVE FLOWERING SHRUBS  
RUBUS ALBUS, ALBOPIUS, RUBUS ALBUS, ALBOPIUS, EUONYMUS EUROPAEUS
- BIRD & BAT BOXES IN SUITABLE LOCATIONS AS ADVISED BY ECOLOGIST

| Rev. | Description:  | Date:    |
|------|---|----------|
| A    | Tree planting updated with Arb report, lighting plans | 11-11-20 |
| B    | Tree planting updated                                 | 22-12-20 |
| C    | Plan updated to show information on Access Plan       | 13-4-202 |
| D    | Tree planting locations updated                       | 17-2-202 |
| E    | Property boundary and tree planting locations updated | 24-4-21  |

**City Design Group**  
Place Shaping Team  
Urban Design and Conservation Team

Client: Strategic City Transport  
Project Title: Ashley Down Station  
Drawing Title: Landscape Plan

Information Status: OUTLINE  
Drawn: LE Checked: VW Date: 9.07.2

Project No: E17052 - 001 Scale: 1:200@A  
Dwg No: 0001 Revision: